


111430N
442520E

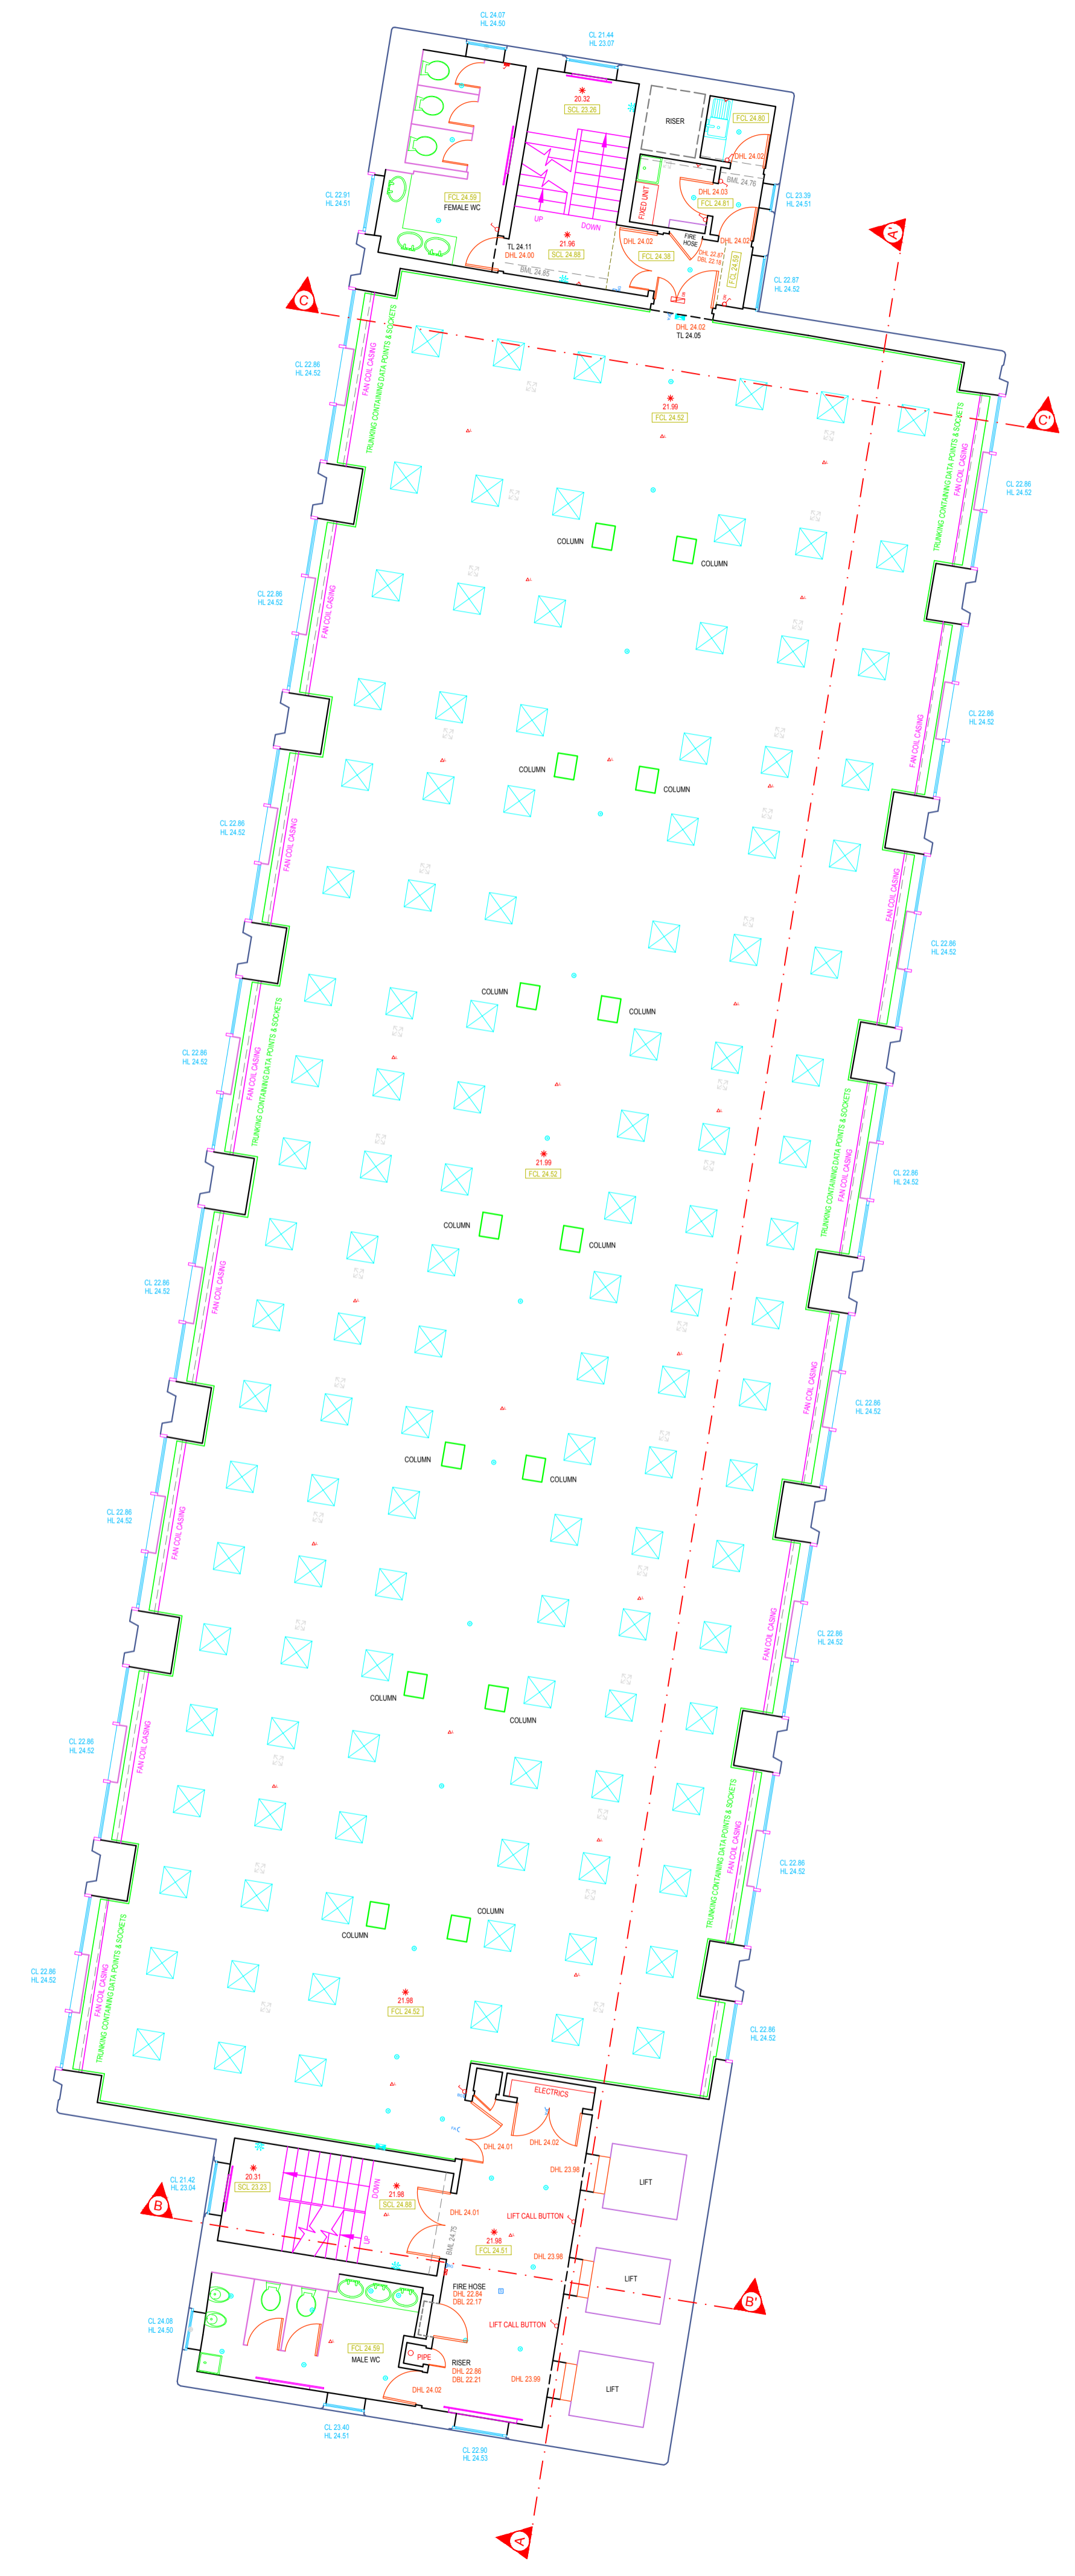

442520E
111380W

Notes
This drawing and the information contained therein is issued in confidence and is the copyright of MT Surveys Ltd. Disclosure of this information to Third Parties and unauthorised copying or replication of this data without approval is forbidden.

Direction of North

GRID
OS NATIONAL GRID.
Using the OS GPS Network and applying OSTN02 transformation and then removing the scale factor for true distances.

DATUM
OS LEVEL DATUM.
Using the OS GPS Network and applying OSGM02 National Geoid Model to obtain local area corrections.

BUILDING SURVEY KEY

CEILING HEIGHTS		WINDOW HEIGHTS	
SCH 2.22	Floor to Structural Ceiling	F-C 1.43	Floor to Cill
FCH 2.22	Floor to False Ceiling	C-H 2.29	Cill to Head
APX 2.22	Floor to Ceiling Apex	C-SPR 1.43	Cill to Spring
SPR 2.22	Floor to Ceiling Spring	C-APX 2.29	Cill to Apex
SCL 0.00	Level to Structural Ceiling	CL 0.00	Cill Level
FCL 0.00	Level to False Ceiling	HL 0.00	Head Level
APL 0.00	Level to Ceiling Apex	APL 0.00	Level to Apex
SPL 0.00	Level to Ceiling Spring	SPL 0.00	Level to Spring

BEAM HEIGHTS		RECESS HEIGHTS	
BMH 3.52	Floor to U/S of Beam	BH 0.86	Floor to Base
BM SPR 3.52	Floor to U/S of Spring	TH 3.35	Floor or Base to U/S
BM APX 3.52	Floor to U/S of Apex	BL 0.00	Level to Base
BM L 0.00	Level to U/S of Beam	TL 0.00	Level to U/S
BM SPL 0.00	Level to U/S of Spring	APL 0.00	Level to Apex
BM APL 0.00	Level to U/S of Apex	SPL 0.00	Level to Spring

DOOR HEIGHTS		OTHER	
DH 2.67	Floor to U/S Door Frame	TOW 0.00	Top of Wall Level
F-SPR 1.68	Floor to Spring of Door	* 0.00	Floor Level
F-APX 2.35	Floor to Apex of Door		
DBL 0.00	Level to Base of Door		
DHL 0.00	Level to U/S Door Frame		
DAPL 0.00	Level to U/S Apex of Door	ANNOTATION	
DSPL 0.00	Level to U/S Spring of Door	AH	Access Hatch
		SKY	Skylight

ELECTRICAL SYMBOLS

Light Switch (tags=switches)	Twin Pole, 2 Way
Pull Cord Switch	Light Switch Dimmer
Single Socket	Double Socket
Single Socket (Light)	Double Socket (Light)
Electricity Supply	Blanking Plate
Fused Spur	Switched Fused Spur
Isolator Switch	Pull Cord Panic Alarm
Telephone Point	Data Point
Aerial Point	Reset Switch
Intercom/Keypad	Magnetic Door Catch
Sensor (Lights)	Sensor (Alarm)
DR Door Release Switch	DR Door Release Break Glass
Fuse Box	Isolation Board
Distribution Board	Electric Meter
360 Ceiling CCTV	CCTV Wall Mounted
Shaver Point	Speaker/Tannoy (Wall)
SP Speaker (Ceiling)	Alarm Keypad

FIRE SERVICES SYMBOLS

Smoke Detector	Sprinkler
Fire Alarm/Sounder	Break Glass
Fire Blanket	Fire Panel
Fire Extinguisher (Small)	Fire Extinguisher (Large)
Fire Hose Reel	

LIGHTING SYMBOLS

Flourescent Tube 1200mm	Flourescent 600mm
Emergency Light	Floodlight
Emergency Exit Light	Pendant Luminaire
Spotlight	Ceiling Luminaire
Spotlight Directional	Wall Light Multi
Wall Light	

HEATING/VENTILATION SYMBOLS

Air Con 600mm	Vent
Heater	Boiler
	Radiator
	Extractor Fan

SERVICES SYMBOLS

Gas Meter	Gas Tap
Water Meter	Water Stop Tap
Hand Dryer	Soil Vent Pipe
Rain Water Pipe	Floor Safe

(w) www.mtsurveys.com
(e) admin@mtsurveys.com
(t) (0)1274 408352

MT Surveys Ltd
Unit 8
Parkview Court
Shipley
BD18 3DZ

CLIENT	DLA Architecture			
SITE	Dukes Keep, Southampton.			
DRAWING TITLE	Measured Floor Plan Survey 6th Floor			
DRAWING REF-(LAYOUT TAB)	1101-145_6 (A1)	SCALE@A1	1/100	
PROJECT REF	1101-145	REV	Ø	
SURVEYED	WS	DRAWN	CC	
CHECKED	MT	DATE	23/09/2019	
REV	DATE	DRAWN	DESCRIPTION	CHECKED